
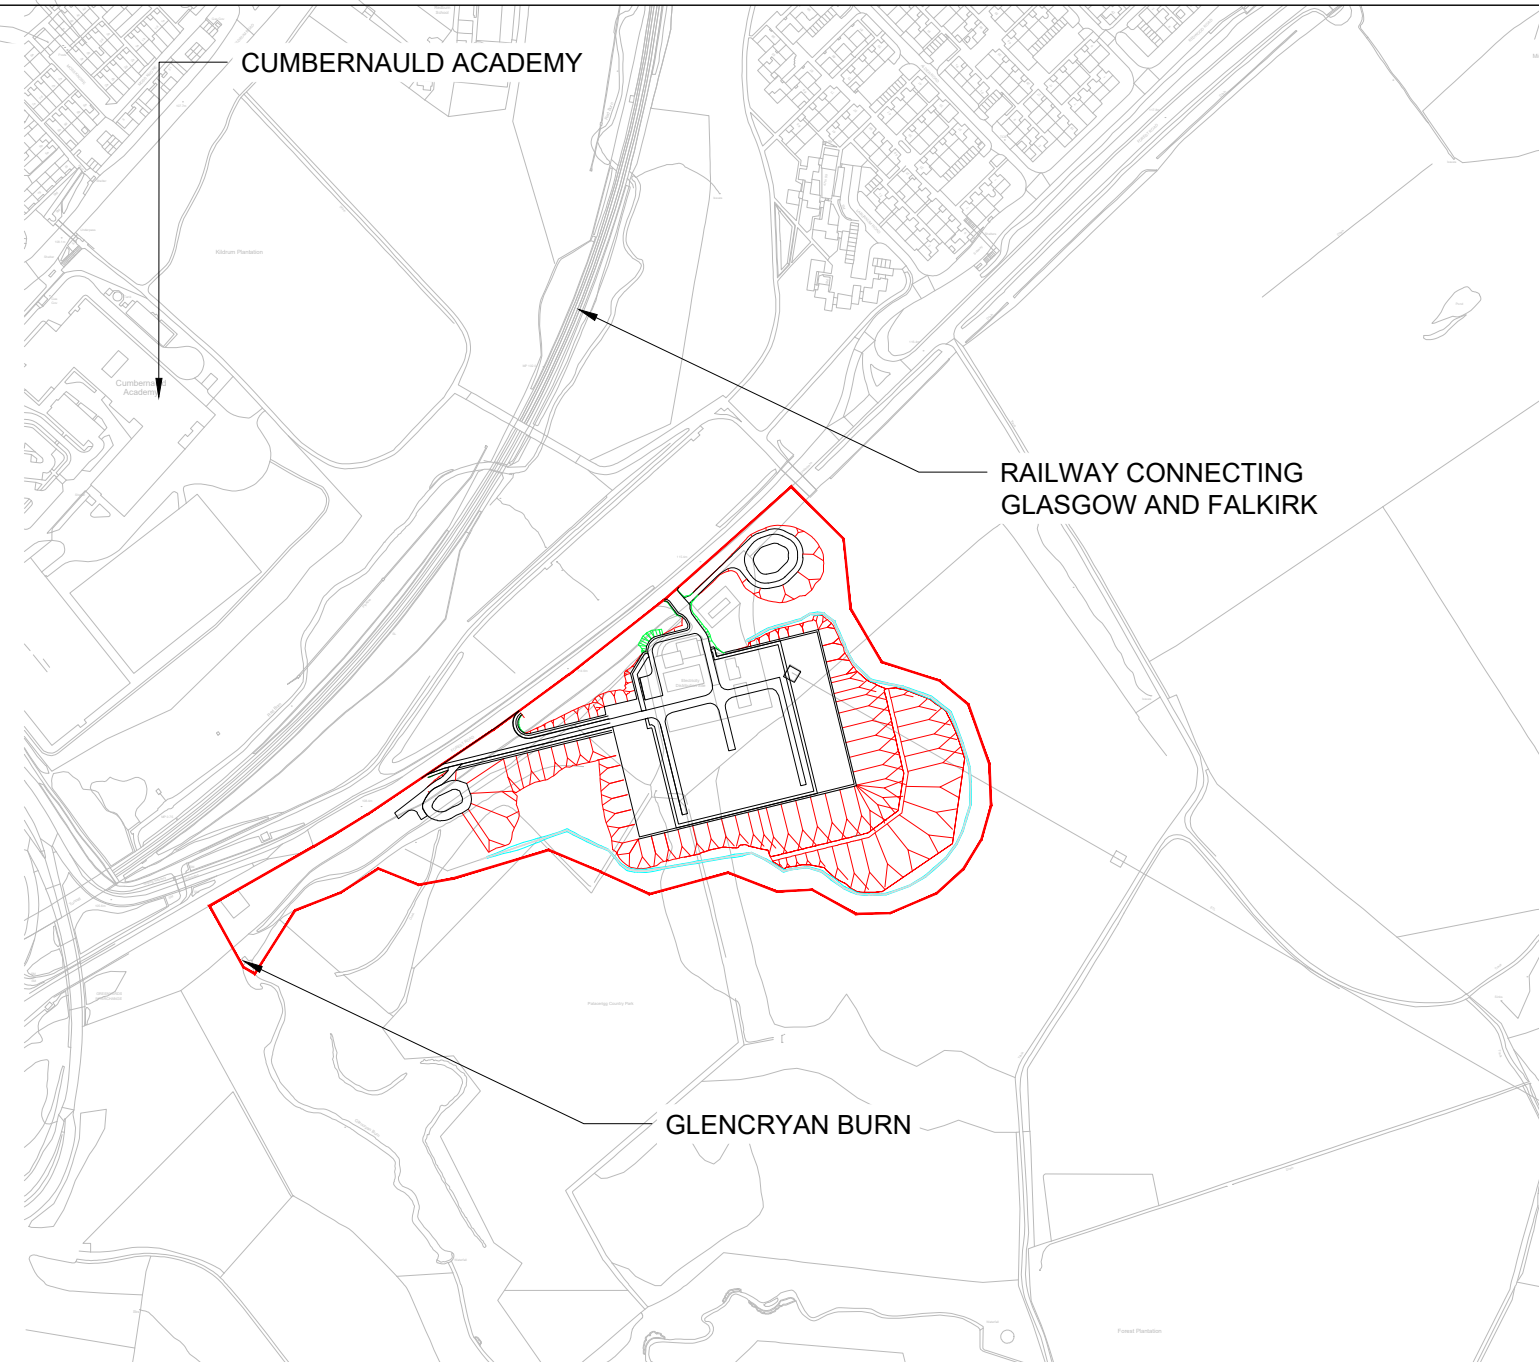


 
 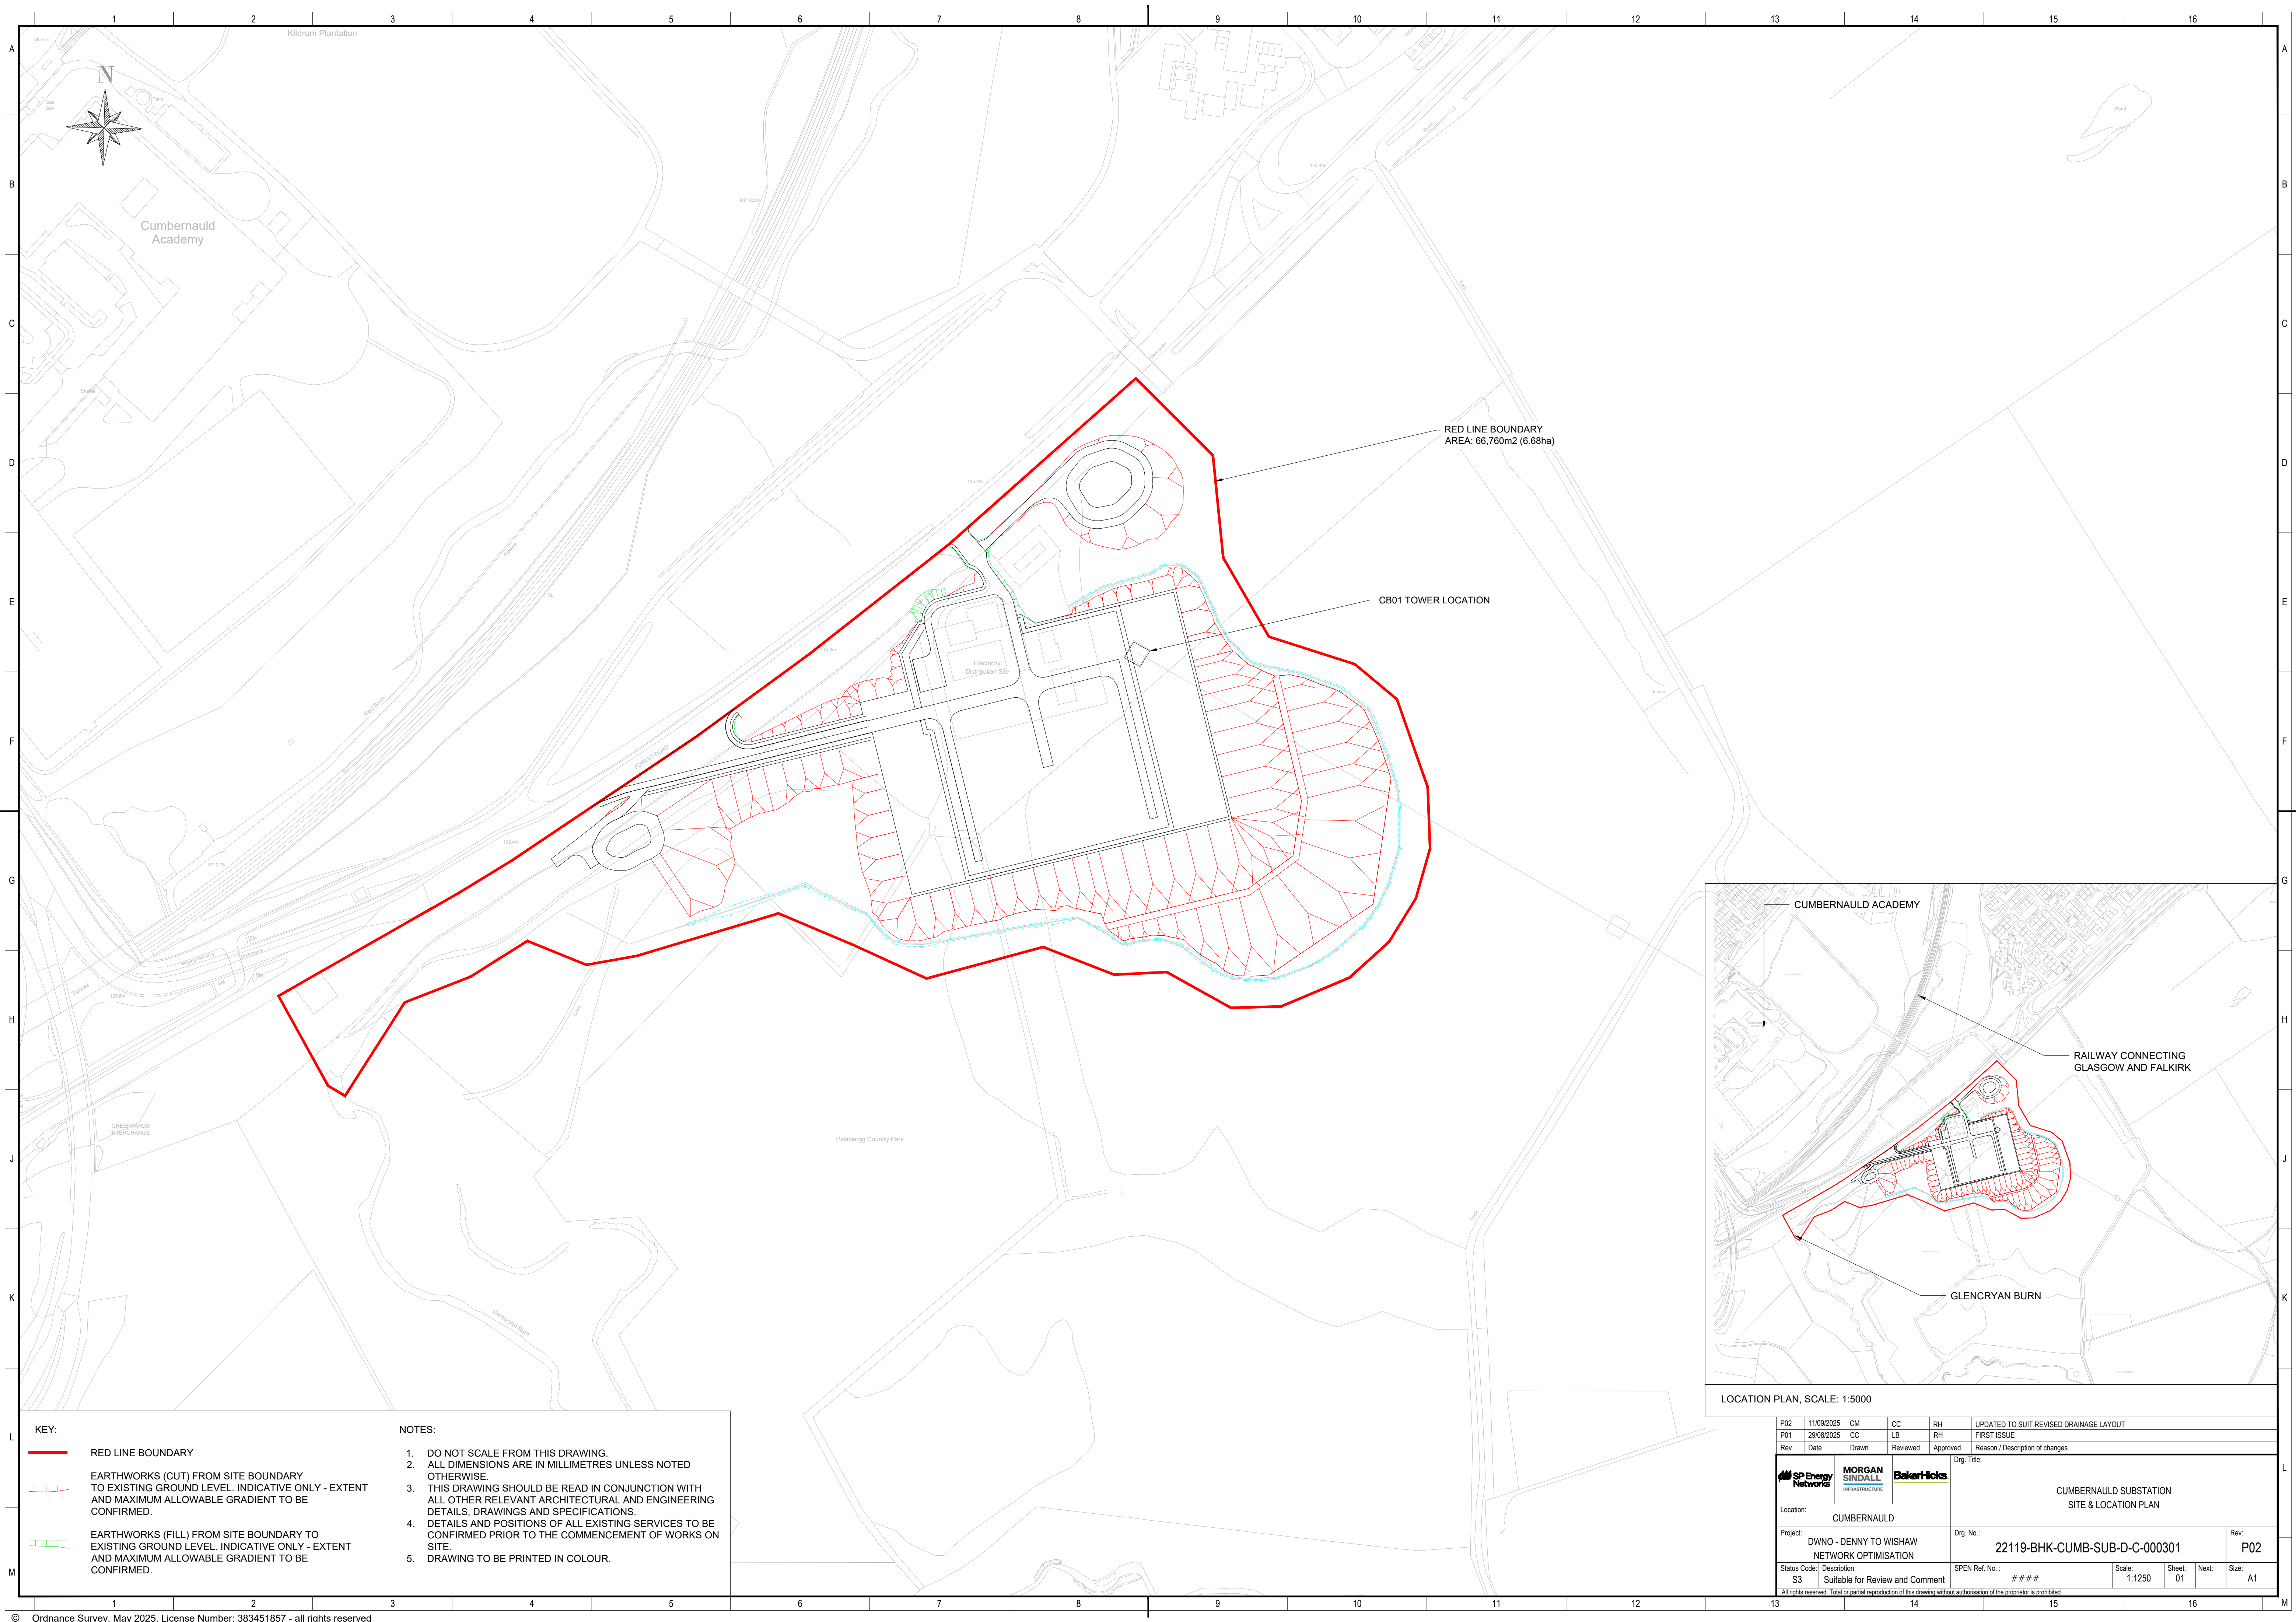


LOCATION PLAN, SCALE: 1:5000

- KEY:**

 - RED LINE BOUNDARY**
 - EARTHWORKS (CUT) FROM SITE BOUNDARY TO EXISTING GROUND LEVEL. INDICATIVE ONLY - EXTENT AND MAXIMUM ALLOWABLE GRADIENT TO BE CONFIRMED.**
 - EARTHWORKS (FILL) FROM SITE BOUNDARY TO EXISTING GROUND LEVEL. INDICATIVE ONLY - EXTENT AND MAXIMUM ALLOWABLE GRADIENT TO BE CONFIRMED.**
- NOTES:**

 - DO NOT SCALE FROM THIS DRAWING.
 - ALL DIMENSIONS ARE IN MILLIMETRES UNLESS NOTED OTHERWISE.
 - THIS DRAWING SHOULD BE READ IN CONJUNCTION WITH ALL OTHER RELEVANT ARCHITECTURAL AND ENGINEERING DETAILS, DRAWINGS AND SPECIFICATIONS.
 - DETAILS AND POSITIONS OF ALL EXISTING SERVICES TO BE CONFIRMED PRIOR TO THE COMMENCEMENT OF WORKS ON SITE.
 - DRAWING TO BE PRINTED IN COLOUR.

P02	11/09/2025	CM	CC	RH	UPDATED TO SUIT REVISED DRAINAGE LAYOUT	
P01	29/08/2025	CC	LB	RH	FIRST ISSUE	
Rev.	Date	Drawn	Reviewed	Approved	Reason / Description of changes.	
						
Location: CUMBERNAULD				Drg. Title: CUMBERNAULD SUBSTATION SITE & LOCATION PLAN		
Project: DWNO - DENNY TO WISHAW NETWORK OPTIMISATION				Drg. No.: 22119-BHK-CUMB-SUB-D-C-000301		Rev: P02
Status Code: S3	Description: Suitable for Review and Comment	SPEN Ref. No.: #####		Scale: 1:1250	Sheet: 01	Next: Size: A1
All rights reserved. Total or partial reproduction of this drawing without authorisation of the proprietor is prohibited.						