


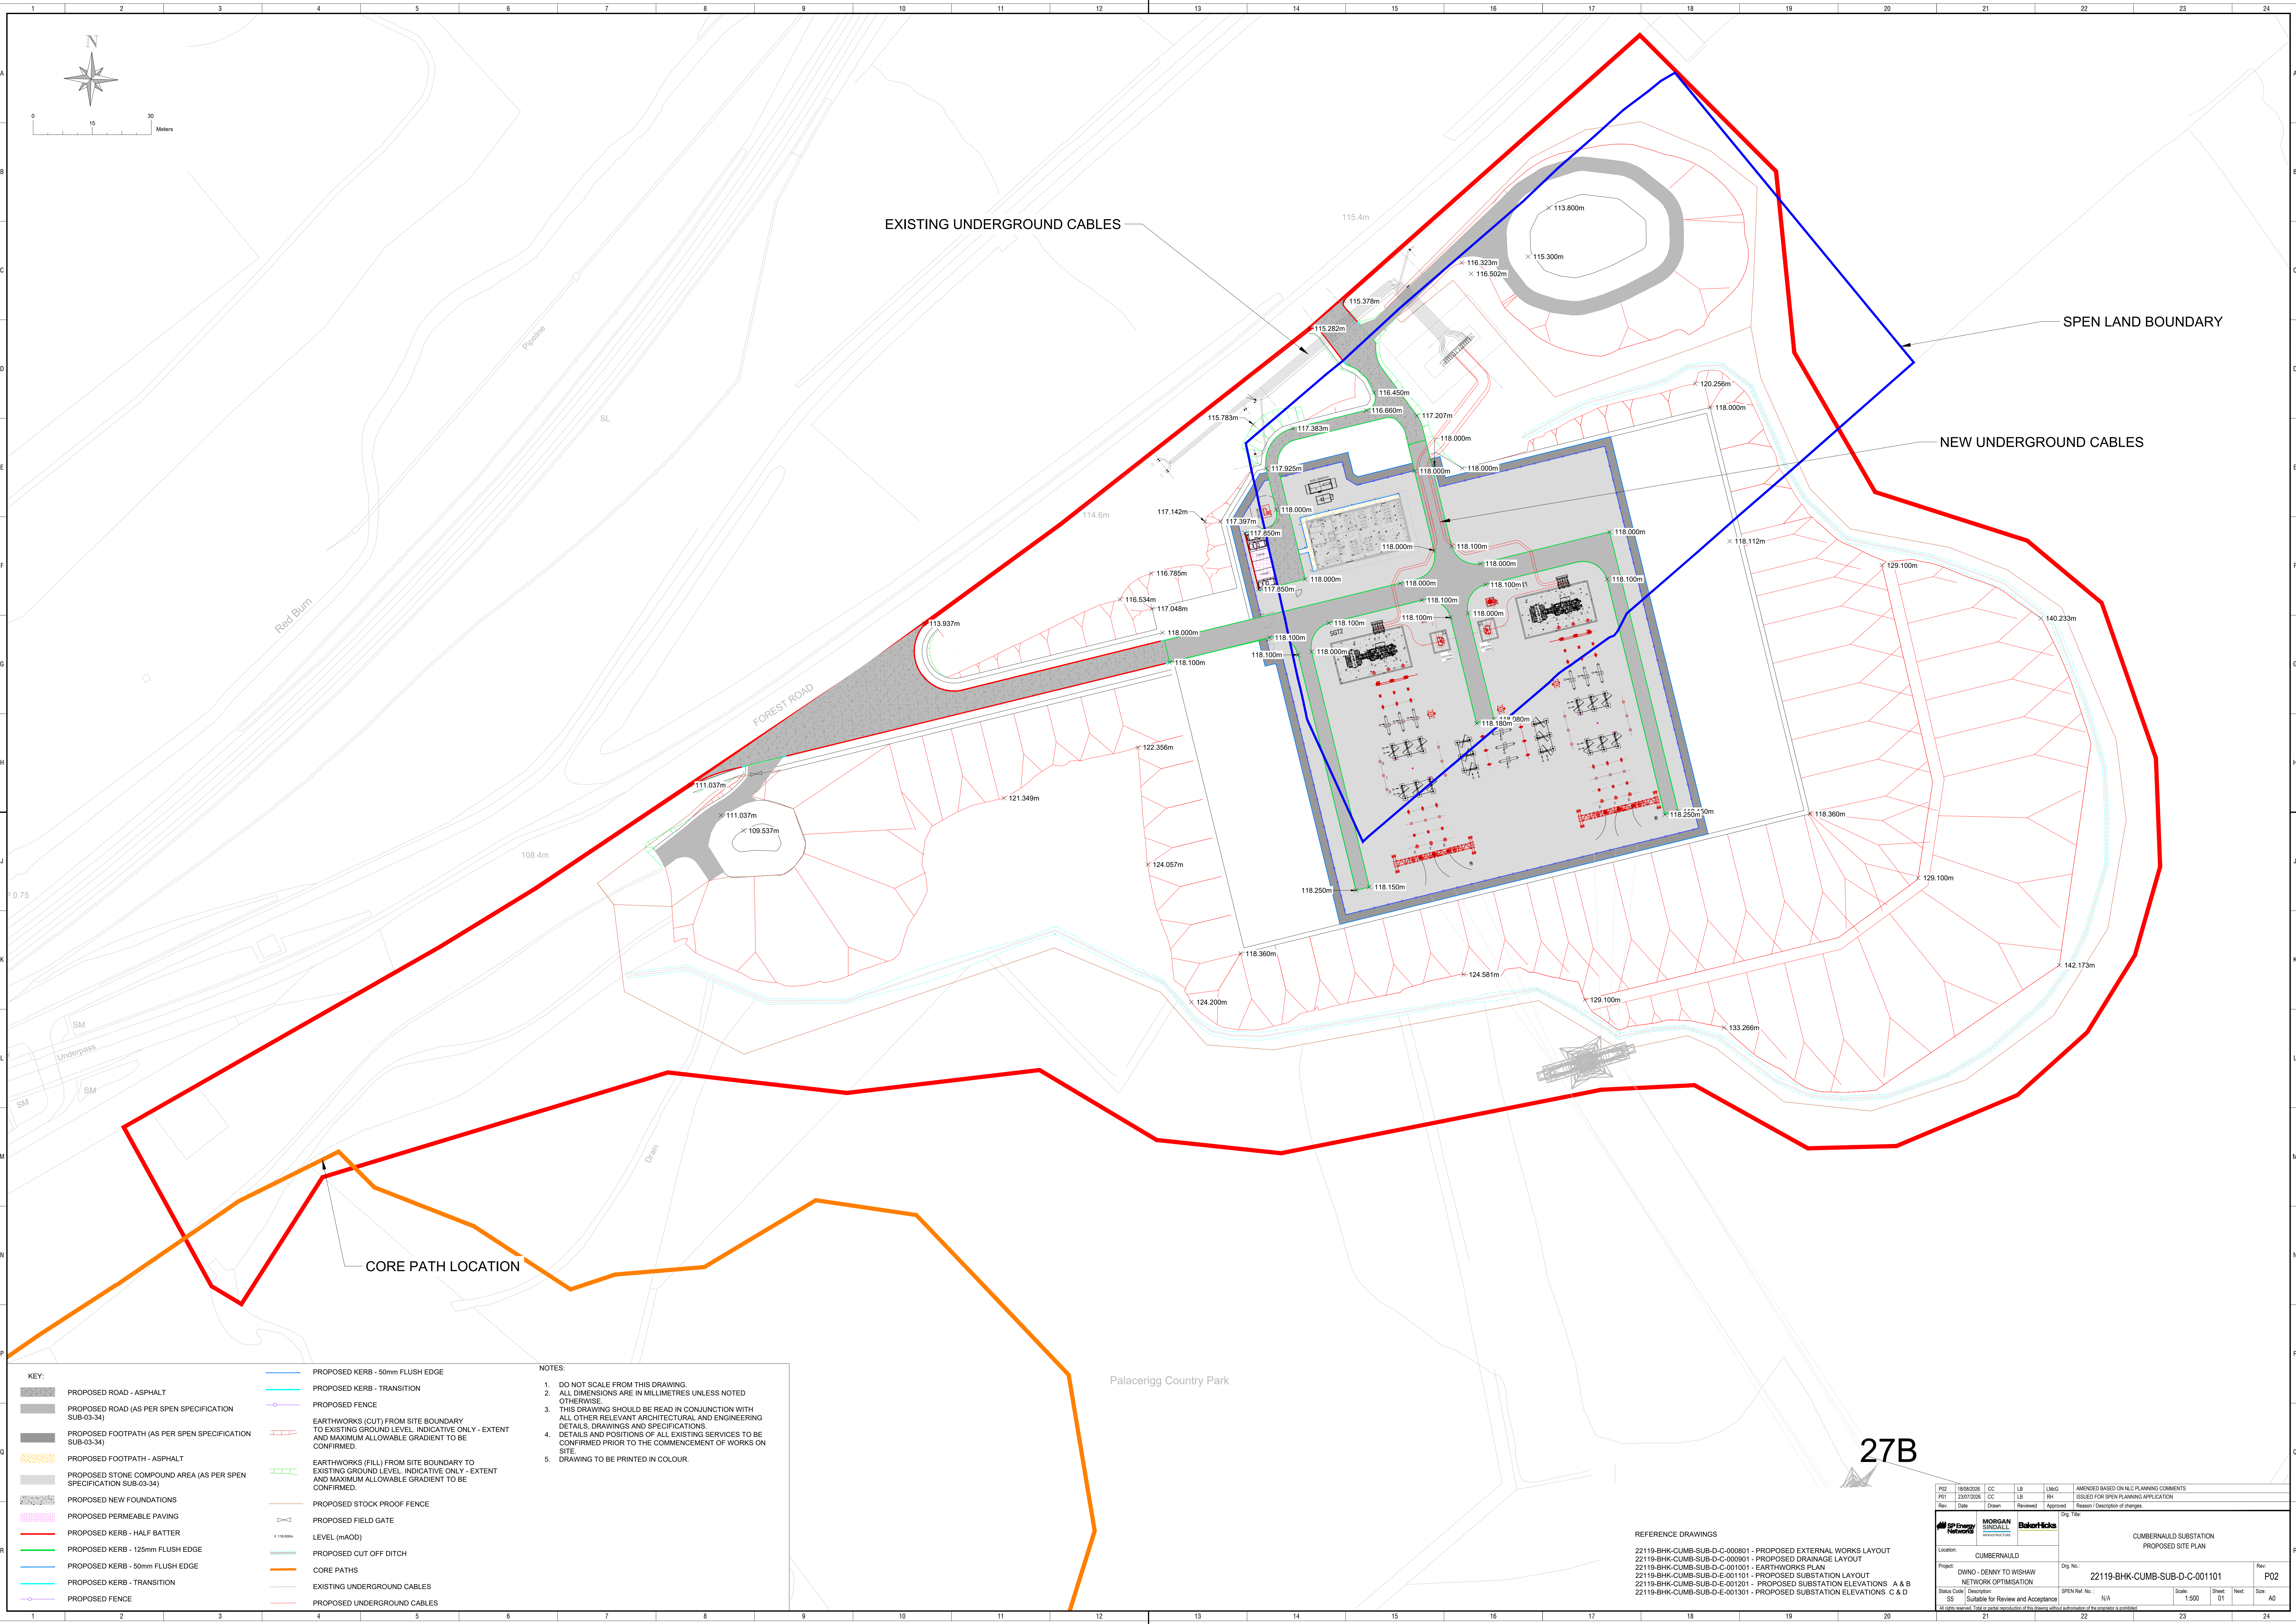

KEY:

PROPOSED ROAD - ASPHALT

PROPOSED ROAD (AS PER SPEN SPECIFICATION SUB-03-34)

PROPOSED FOOTPATH (AS PER SPEN SPECIFICATION SUB-03-34)

PROPOSED FOOTPATH - ASPHALT

PROPOSED STONE COMPOUND AREA (AS PER SPEN SPECIFICATION SUB-03-34)

PROPOSED NEW FOUNDATIONS

PROPOSED PERMEABLE PAVING

PROPOSED KERB - HALF BATTER

PROPOSED KERB - 125mm FLUSH EDGE

PROPOSED KERB - 50mm FLUSH EDGE

PROPOSED KERB - TRANSITION

PROPOSED FENCE

PROPOSED KERB - 50mm FLUSH EDGE

PROPOSED KERB - TRANSITION

PROPOSED FENCE

EARTHWORKS (CUT) FROM SITE BOUNDARY TO EXISTING GROUND LEVEL. INDICATIVE ONLY - EXTENT AND MAXIMUM ALLOWABLE GRADIENT TO BE CONFIRMED.

EARTHWORKS (FILL) FROM SITE BOUNDARY TO EXISTING GROUND LEVEL. INDICATIVE ONLY - EXTENT AND MAXIMUM ALLOWABLE GRADIENT TO BE CONFIRMED.

PROPOSED STOCK PROOF FENCE

PROPOSED FIELD GATE

LEVEL (mAOD)

PROPOSED CUT OFF DITCH

CORE PATHS

EXISTING UNDERGROUND CABLES

PROPOSED UNDERGROUND CABLES

NOTES:

1. DO NOT SCALE FROM THIS DRAWING.

2. ALL DIMENSIONS ARE IN MILLIMETRES UNLESS NOTED OTHERWISE.

3. THIS DRAWING SHOULD BE READ IN CONJUNCTION WITH ALL OTHER RELEVANT ARCHITECTURAL AND ENGINEERING DETAILS, DRAWINGS AND SPECIFICATIONS.

4. DETAILS AND POSITIONS OF ALL EXISTING SERVICES TO BE CONFIRMED PRIOR TO THE COMMENCEMENT OF WORKS ON SITE.

5. DRAWING TO BE PRINTED IN COLOUR.

REFERENCE DRAWINGS

22119-BHK-CUMB-SUB-D-C-000801 - PROPOSED EXTERNAL WORKS LAYOUT
22119-BHK-CUMB-SUB-D-C-000901 - PROPOSED DRAINAGE LAYOUT
22119-BHK-CUMB-SUB-D-C-001001 - EARTHWORKS PLAN
22119-BHK-CUMB-SUB-D-E-001101 - PROPOSED SUBSTATION LAYOUT
22119-BHK-CUMB-SUB-D-E-001201 - PROPOSED SUBSTATION ELEVATIONS A & B
22119-BHK-CUMB-SUB-D-E-001301 - PROPOSED SUBSTATION ELEVATIONS C & D

P02	19/08/2026	CC	LB	LMG	AMENDED BASED ON N/C PLANNING COMMENTS					
P01	23/07/2026	CC	LB	RH	ISSUED FOR SPEN PLANNING APPLICATION					
Rev.	Date	Drawn	Reviewed	Approved	Reason / Description of changes					
SP Energy Networks MORGAN SINDALL Baker Hicks				22119-BHK-CUMB-SUB-D-C-001101						
Location: CUMBERNAULD				CUMBERNAULD SUBSTATION PROPOSED SITE PLAN						
Project: DWNO - DENNY TO WISHAW NETWORK OPTIMISATION				22119-BHK-CUMB-SUB-D-C-001101						
Status Code: S5 Suitable for Review and Acceptance				SPEN Ref: N/A						
All rights reserved. Total or partial reproduction of this drawing without authorisation of the proposer is prohibited.				Scale: 1:500	Sheet: 01	Next: 02	Size: A0			