


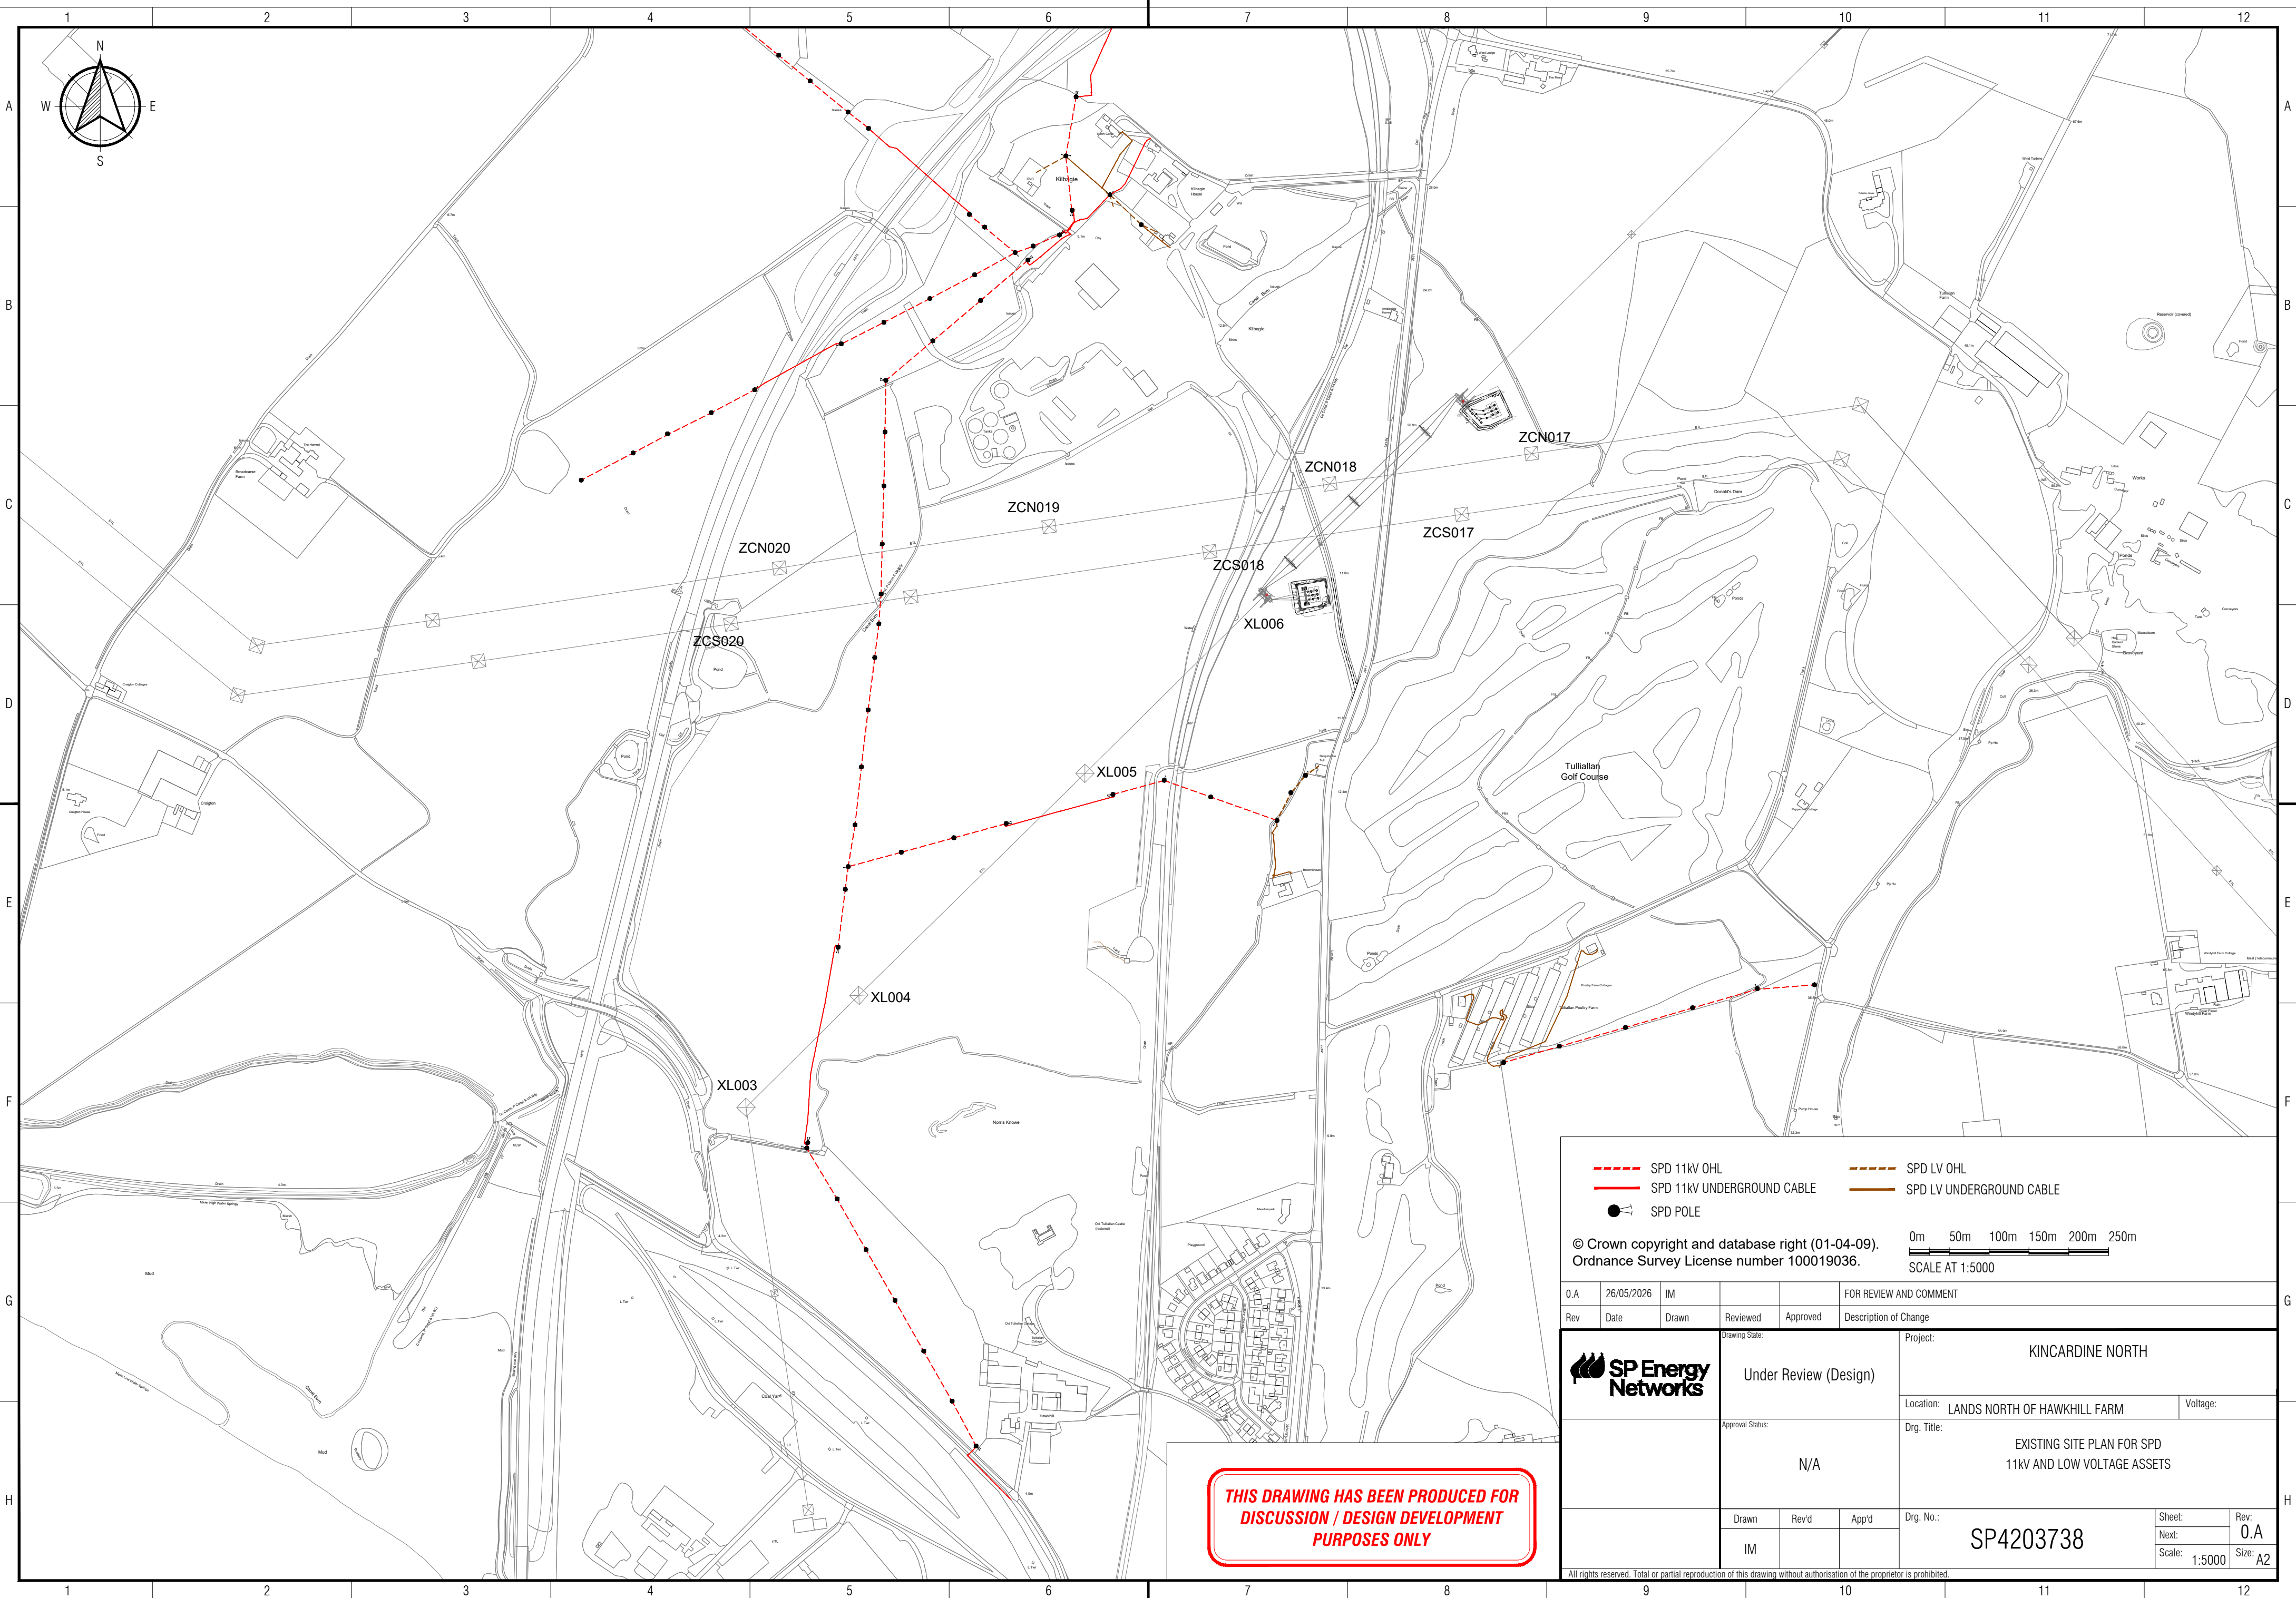

SPD 11kV OHL

SPD 11kV UNDERGROUND CABLE

SPD LV OHL

SPD LV UNDERGROUND CABLE

SPD POLE

© Crown copyright and database right (01-04-09).
Ordnance Survey License number 100019036.

0m50m100m150m200m250m

SCALE AT 1:5000

0.A	26/05/2026	IM			FOR REVIEW AND COMMENT
Rev	Date	Drawn	Reviewed	Approved	Description of Change

	Drawing State:		Project:		
	Under Review (Design)		KINCARDINE NORTH		
	Approval Status:		Location:		
	N/A		LANDS NORTH OF HAWKHILL FARM		
			Voltage:		
			Drg. Title:		
			EXISTING SITE PLAN FOR SPD 11kV AND LOW VOLTAGE ASSETS		
		Drawn	Rev'd	App'd	Drg. No.:
		IM			SP4203738
					Sheet:
					Next:
					Scale: 1:5000
					Rev: 0.A
					Size: A2

All rights reserved. Total or partial reproduction of this drawing without authorisation of the proprietor is prohibited.

THIS DRAWING HAS BEEN PRODUCED FOR
DISCUSSION / DESIGN DEVELOPMENT
PURPOSES ONLY