


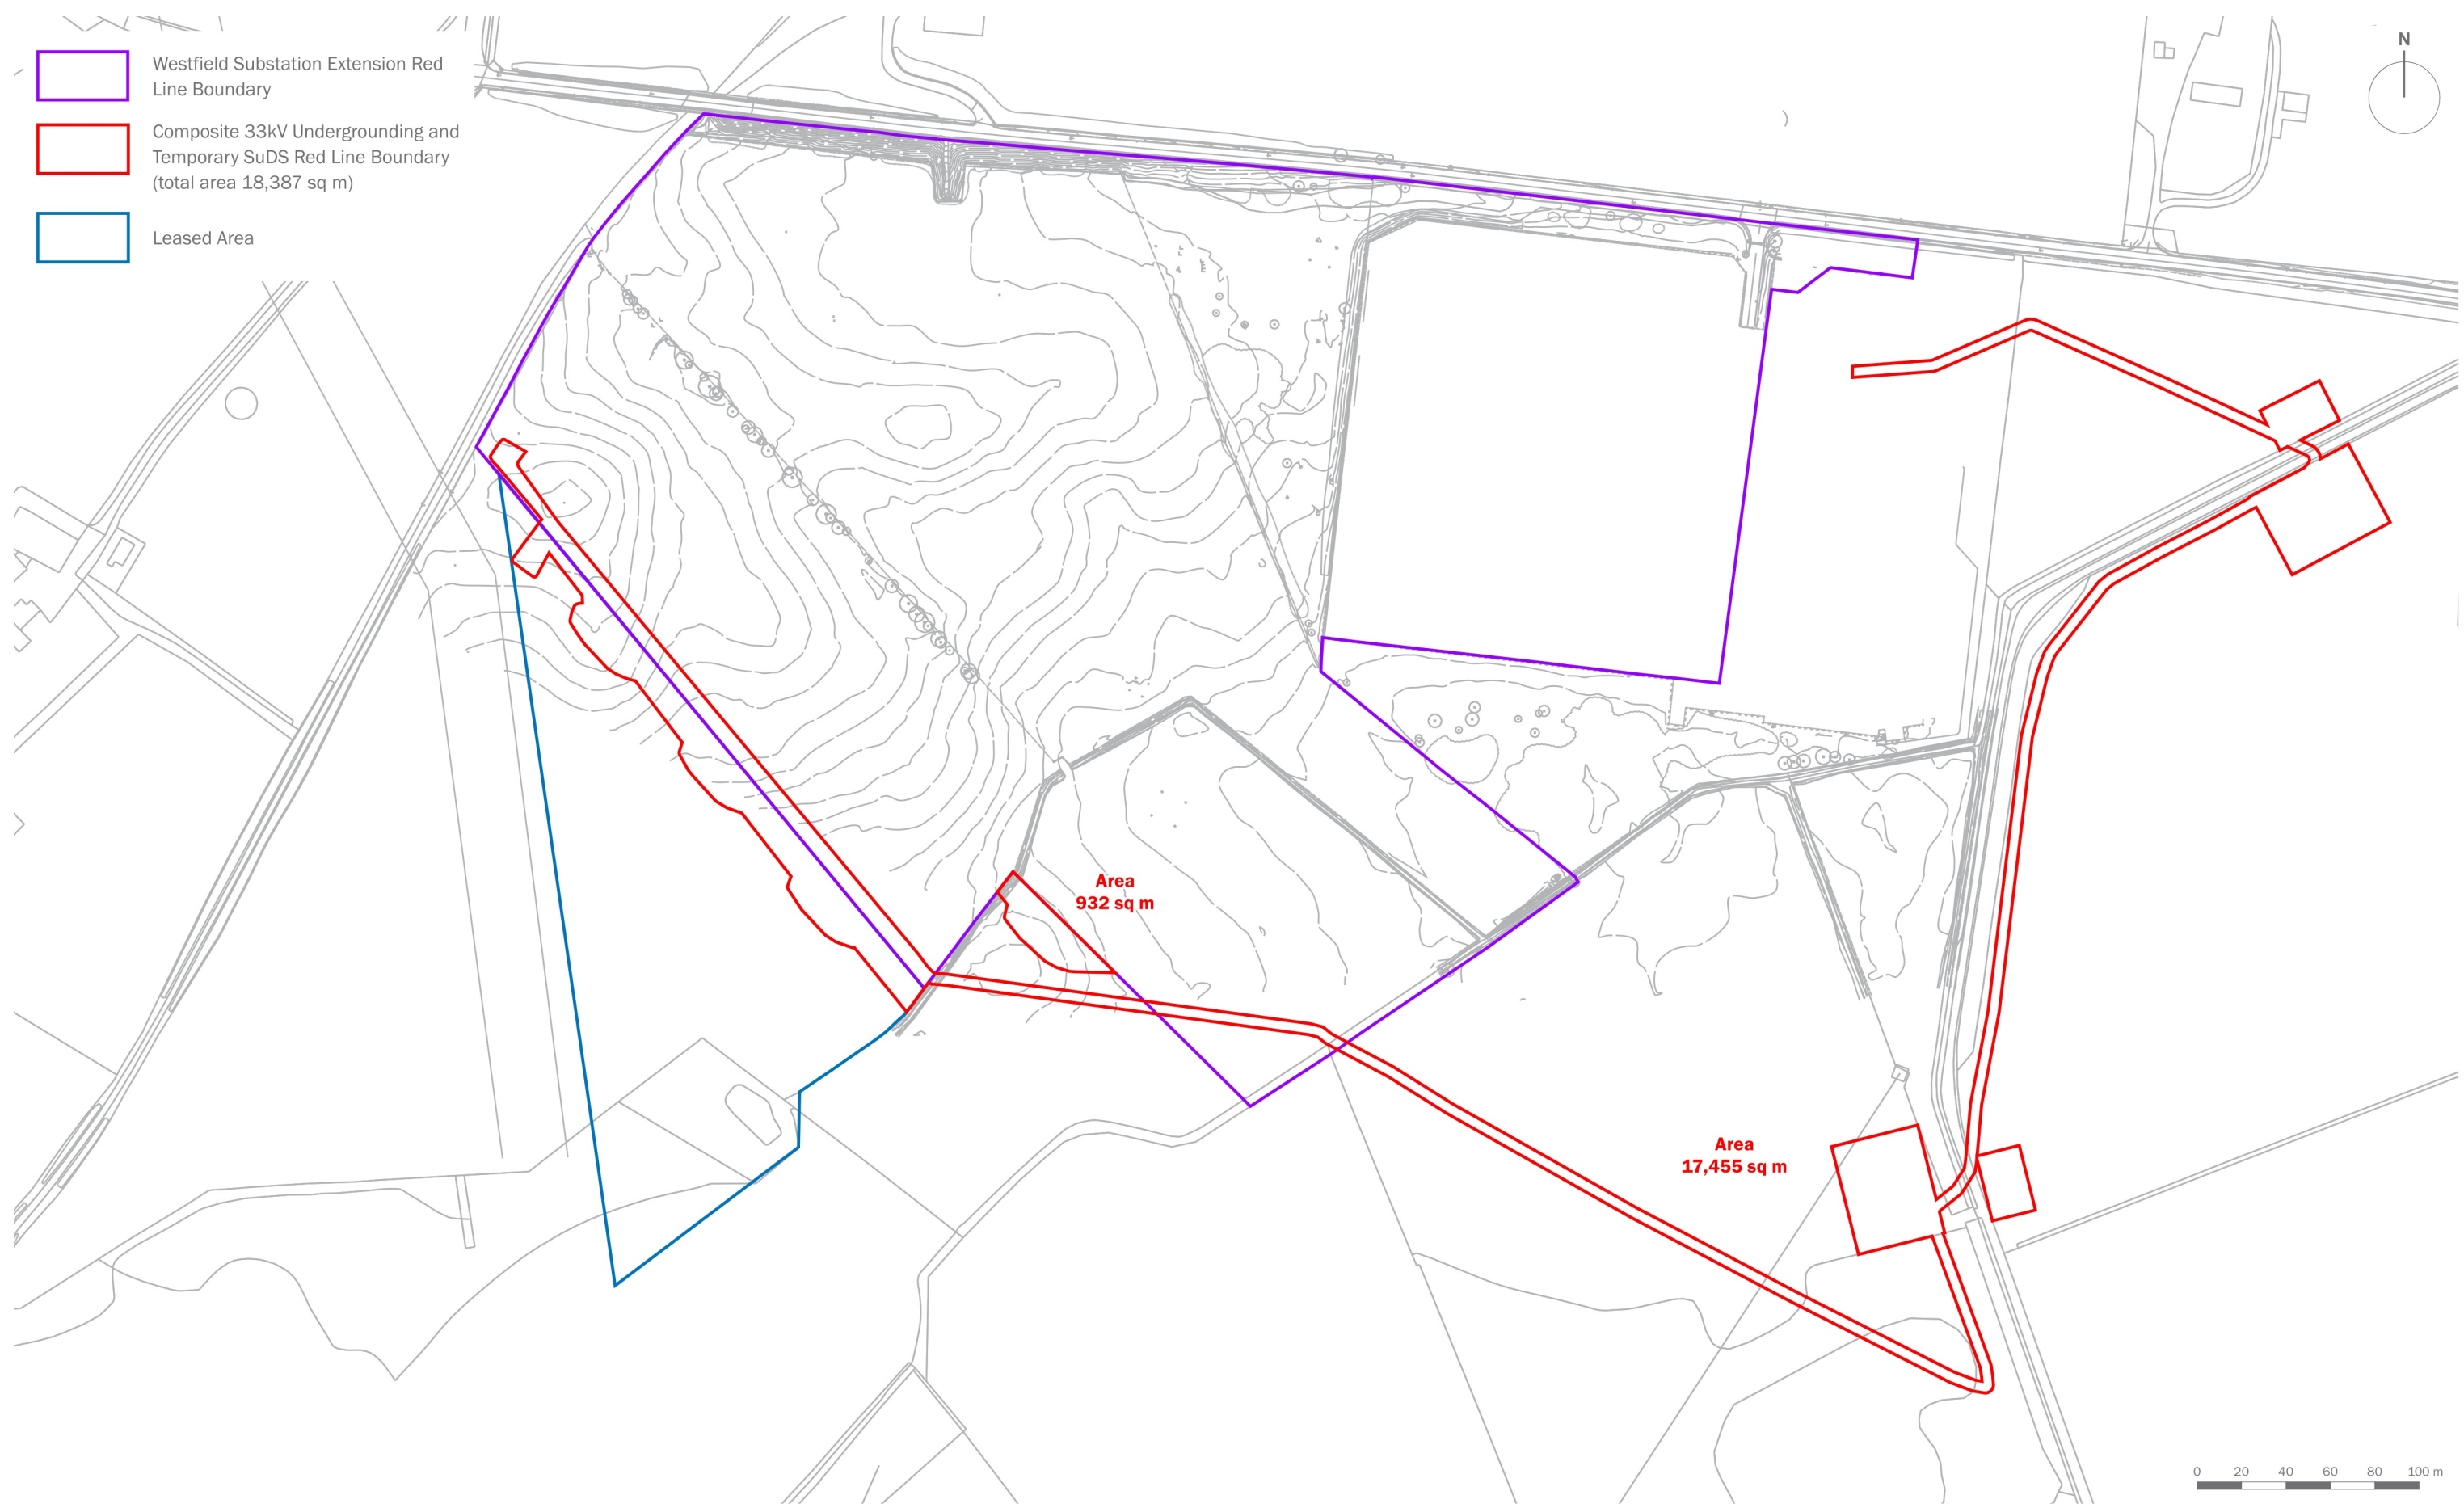

|                                  |  |                                       |  |                                                                                                        |  |
|----------------------------------|--|---------------------------------------|--|--------------------------------------------------------------------------------------------------------|--|
| purpose of issue <b>PLANNING</b> |  | date<br><b>08 SEPTEMBER 2026</b>      |  | client<br><b>SP Transmission</b>                                                                       |  |
|                                  |  | drawing number<br><b>edp8754_d033</b> |  | project title<br><b>Westfield Substation Extension</b>                                                 |  |
|                                  |  | scale<br><b>1:2,750 @ A3</b>          |  | drawing title<br><b>Proposed 33kV Underground Cable, Wood Poles and Temporary Drainage – Site Plan</b> |  |
|                                  |  | drawn by<br><b>DJo</b>                |  |                                                                                                        |  |
|                                  |  | checked<br><b>CMy</b>                 |  |                                                                                                        |  |
|                                  |  | QA<br><b>JFr</b>                      |  |                                                                                                        |  |