
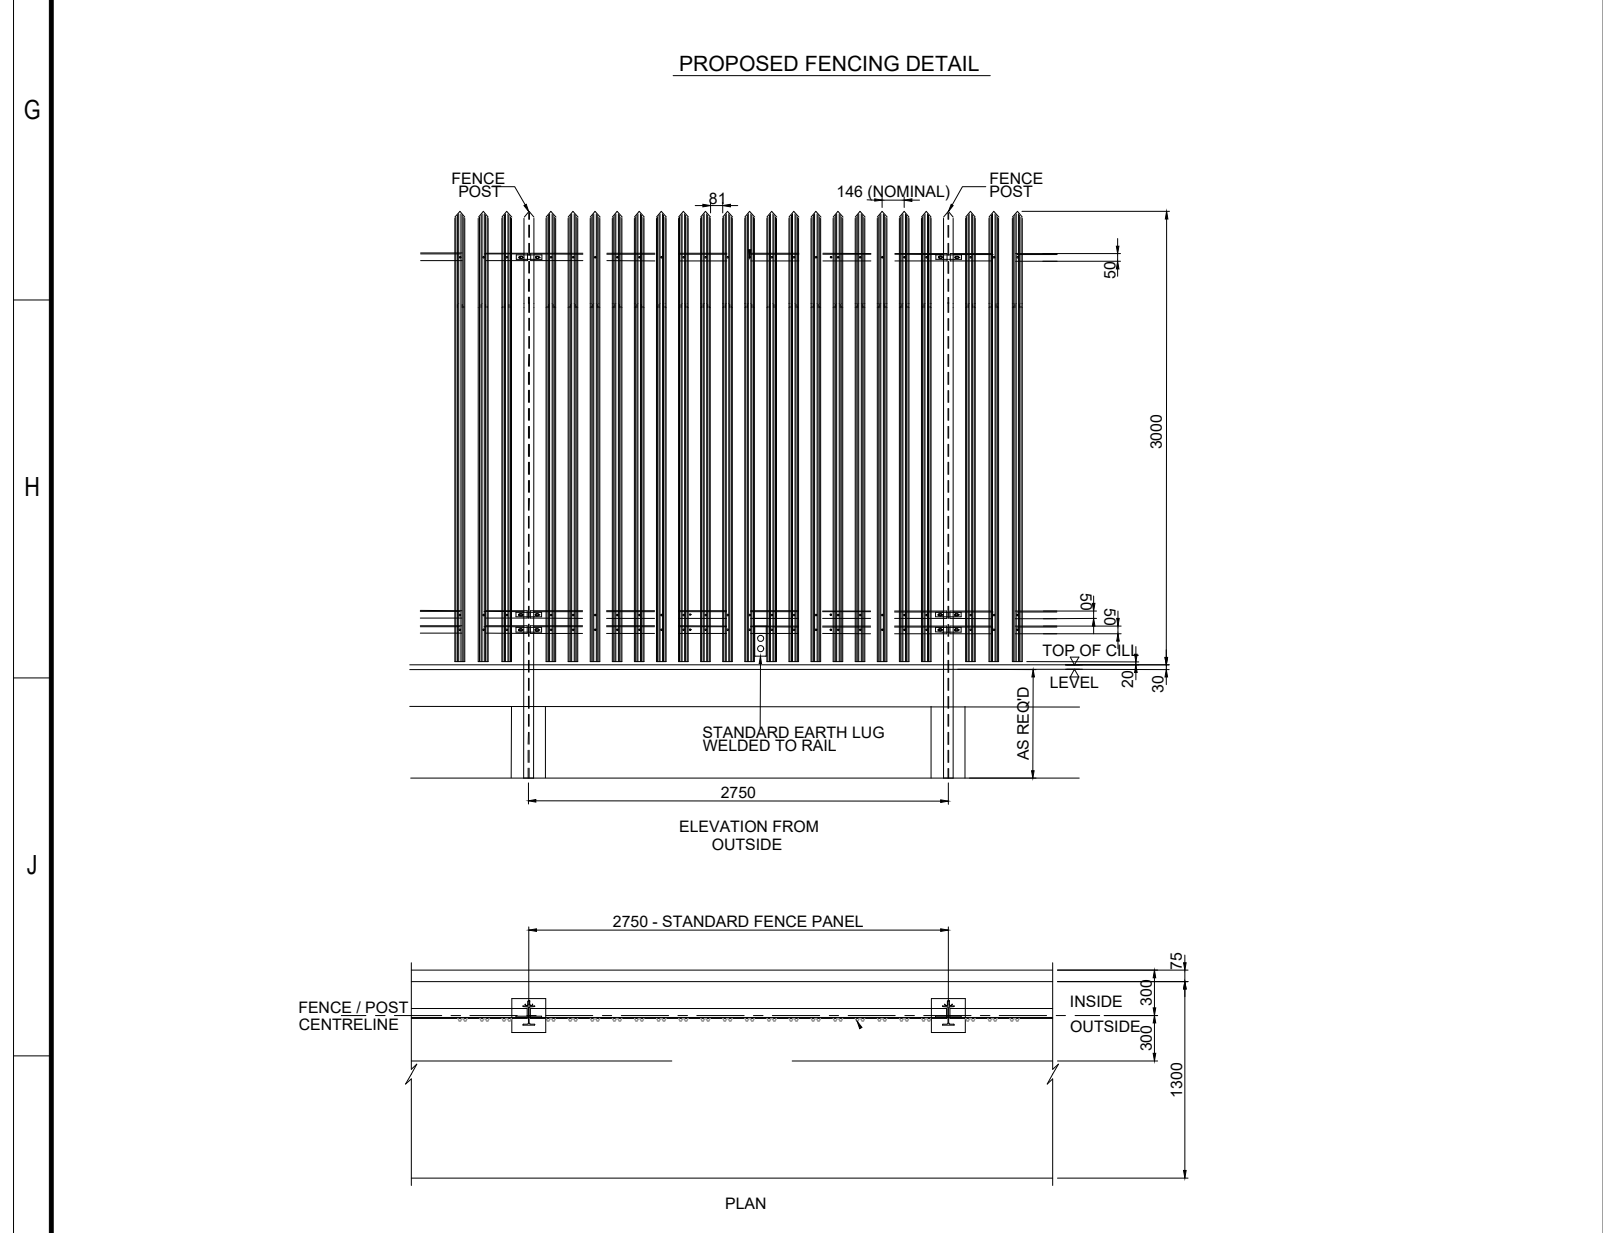


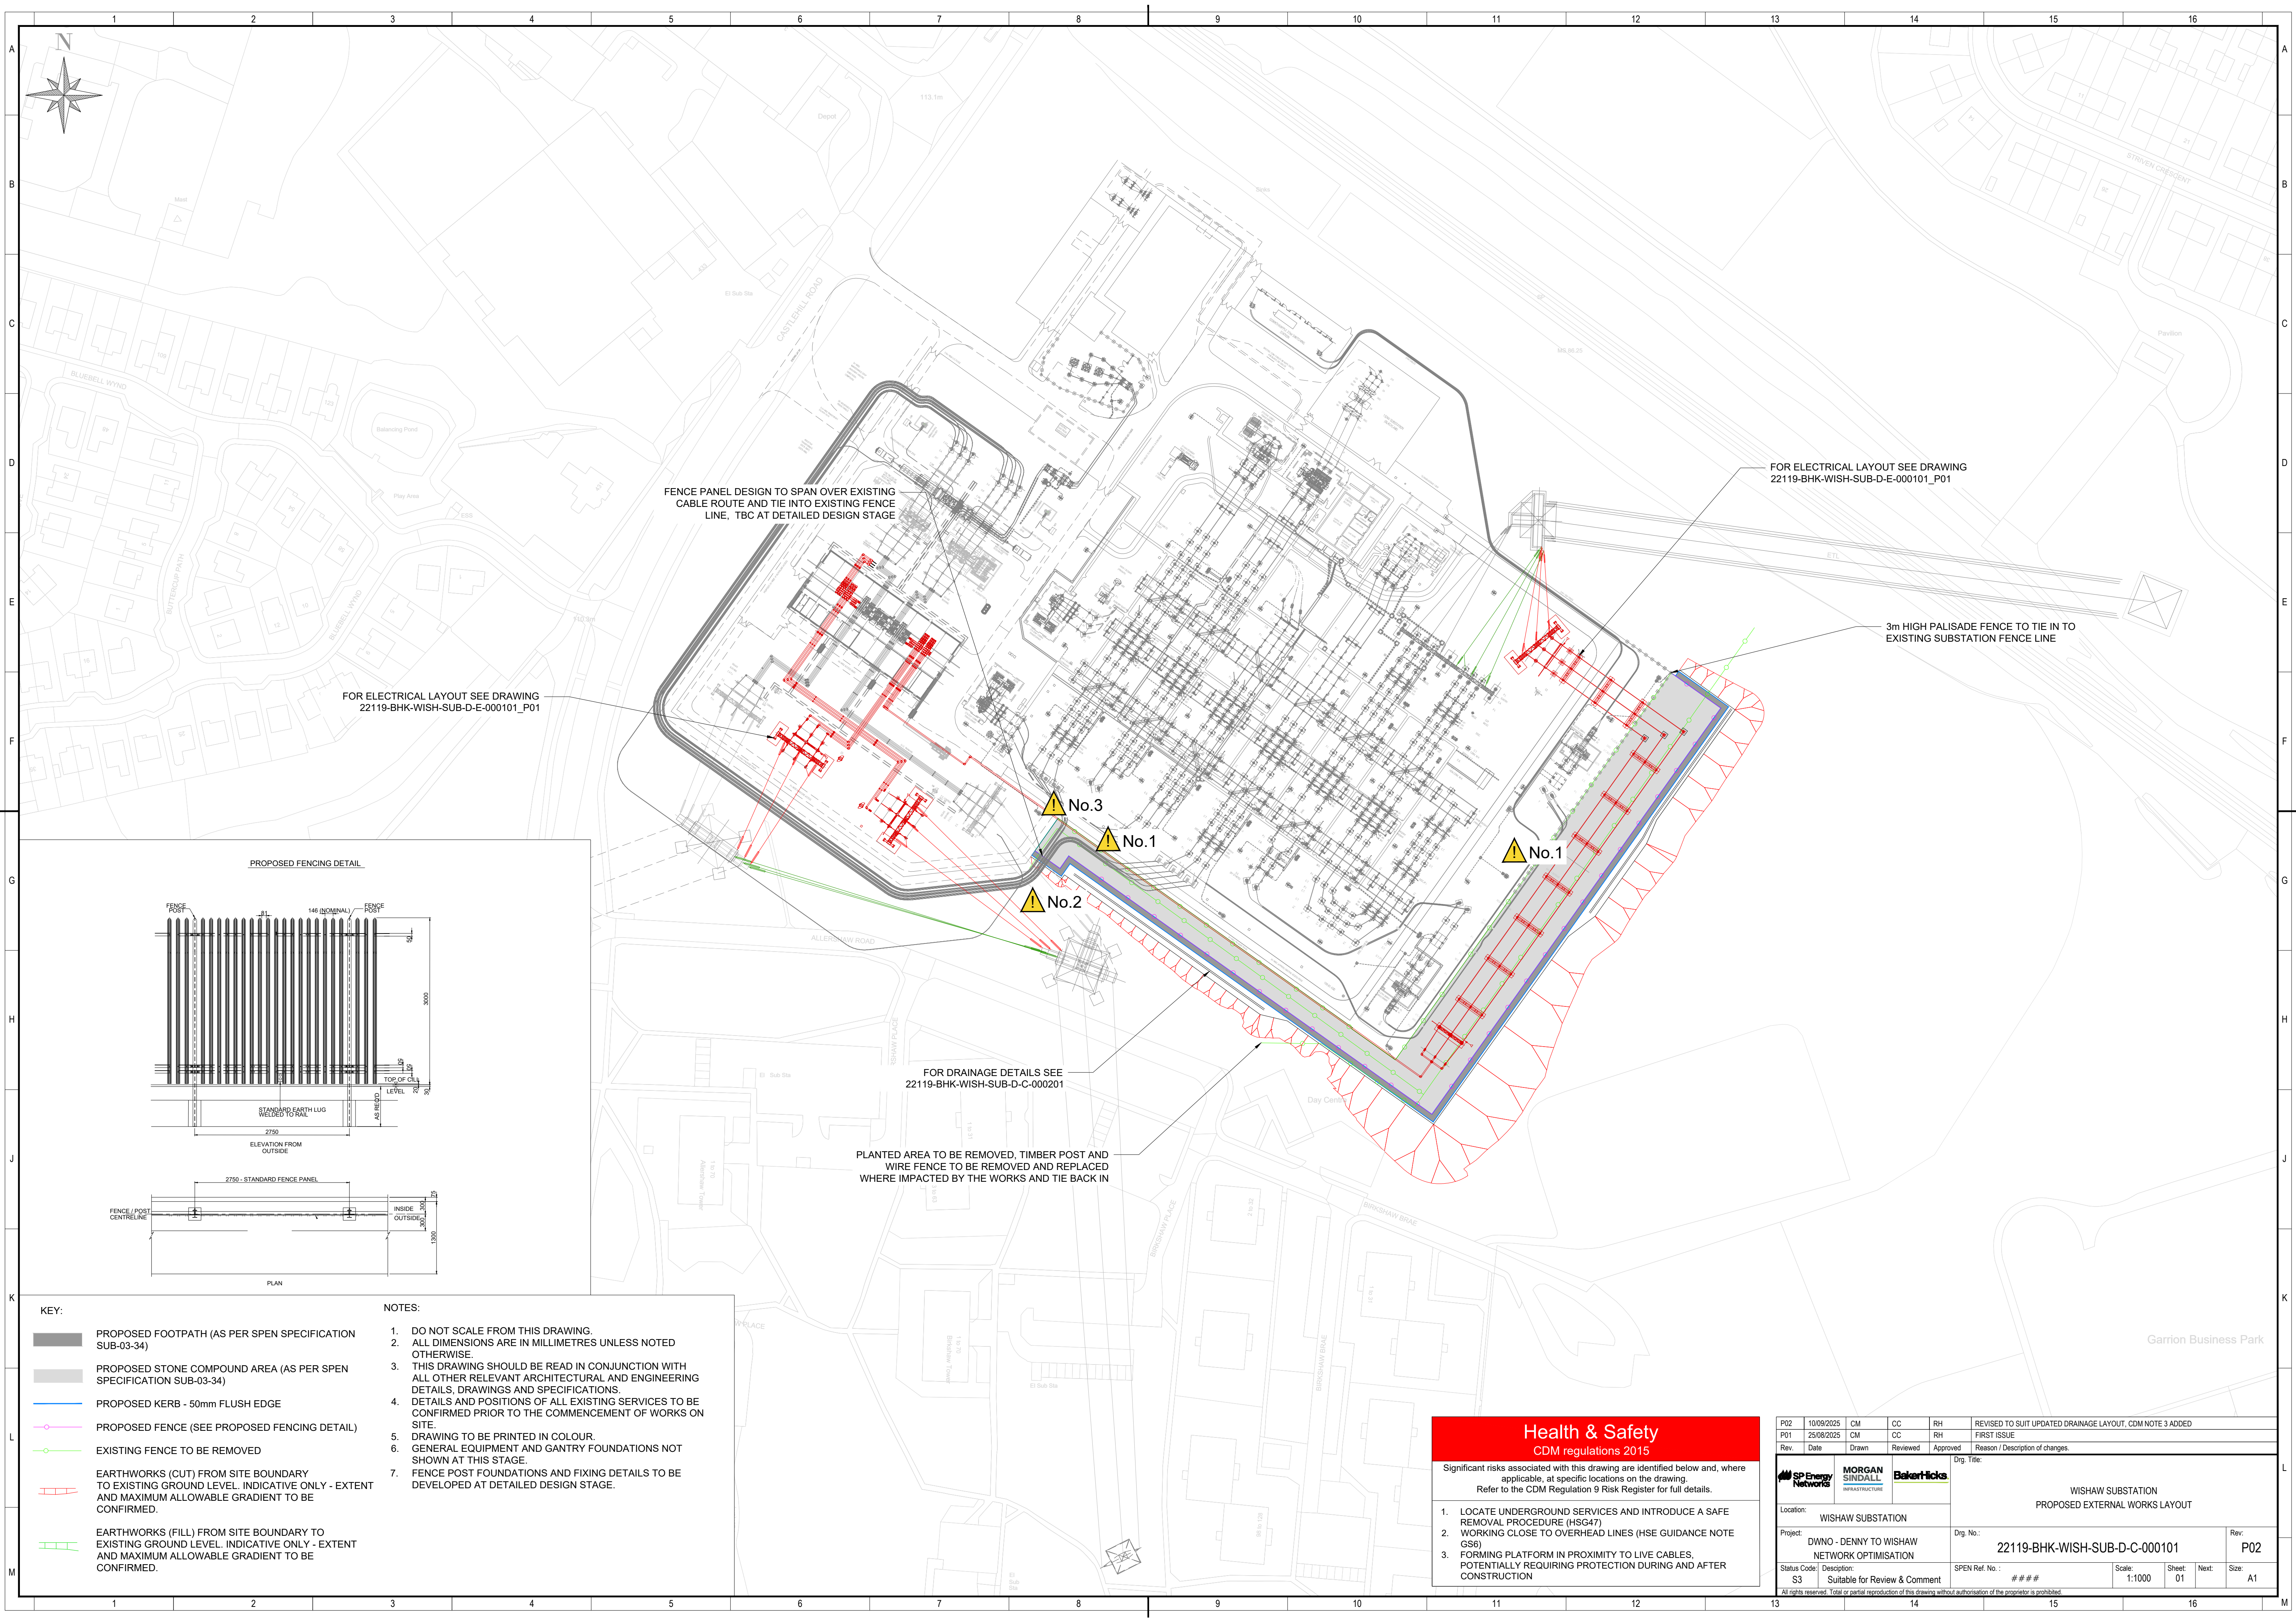

KEY:

- PROPOSED FOOTPATH (AS PER SPEN SPECIFICATION SUB-03-34)
- PROPOSED STONE COMPOUND AREA (AS PER SPEN SPECIFICATION SUB-03-34)
- PROPOSED KERB - 50mm FLUSH EDGE
- PROPOSED FENCE (SEE PROPOSED FENCING DETAIL)
- EXISTING FENCE TO BE REMOVED
- EARTHWORKS (CUT) FROM SITE BOUNDARY TO EXISTING GROUND LEVEL. INDICATIVE ONLY - EXTENT AND MAXIMUM ALLOWABLE GRADIENT TO BE CONFIRMED.
- EARTHWORKS (FILL) FROM SITE BOUNDARY TO EXISTING GROUND LEVEL. INDICATIVE ONLY - EXTENT AND MAXIMUM ALLOWABLE GRADIENT TO BE CONFIRMED.

NOTES:

- DO NOT SCALE FROM THIS DRAWING.
- ALL DIMENSIONS ARE IN MILLIMETRES UNLESS NOTED OTHERWISE.
- THIS DRAWING SHOULD BE READ IN CONJUNCTION WITH ALL OTHER RELEVANT ARCHITECTURAL AND ENGINEERING DETAILS, DRAWINGS AND SPECIFICATIONS.
- DETAILS AND POSITIONS OF ALL EXISTING SERVICES TO BE CONFIRMED PRIOR TO THE COMMENCEMENT OF WORKS ON SITE.
- DRAWING TO BE PRINTED IN COLOUR.
- GENERAL EQUIPMENT AND GANTRY FOUNDATIONS NOT SHOWN AT THIS STAGE.
- FENCE POST FOUNDATIONS AND FIXING DETAILS TO BE DEVELOPED AT DETAILED DESIGN STAGE.

Health & Safety
CDM regulations 2015

Significant risks associated with this drawing are identified below and, where applicable, at specific locations on the drawing. Refer to the CDM Regulation 9 Risk Register for full details.

- LOCATE UNDERGROUND SERVICES AND INTRODUCE A SAFE REMOVAL PROCEDURE (HSG47)
- WORKING CLOSE TO OVERHEAD LINES (HSE GUIDANCE NOTE GS6)
- FORMING PLATFORM IN PROXIMITY TO LIVE CABLES, POTENTIALLY REQUIRING PROTECTION DURING AND AFTER CONSTRUCTION

P02	10/09/2025	CM	CC	RH	REVISED TO SUIT UPDATED DRAINAGE LAYOUT, CDM NOTE 3 ADDED
P01	25/08/2025	CM	CC	RH	FIRST ISSUE
Rev.	Date	Drawn	Reviewed	Approved	Reason / Description of changes.
MORGAN SINDALL INFRASTRUCTURE					Drg Title:
Location: WISHAW SUBSTATION					
Project: DWNO - DENNY TO WISHAW NETWORK OPTIMISATION					
Status Code: S3					
Description: Suitable for Review & Comment					
SPEN Ref. No.: ###					
Scale: 1:1000					
Sheet: 01					
Next: Size: A1					
All rights reserved. Total or partial reproduction of this drawing without authorisation of the proprietor is prohibited.					